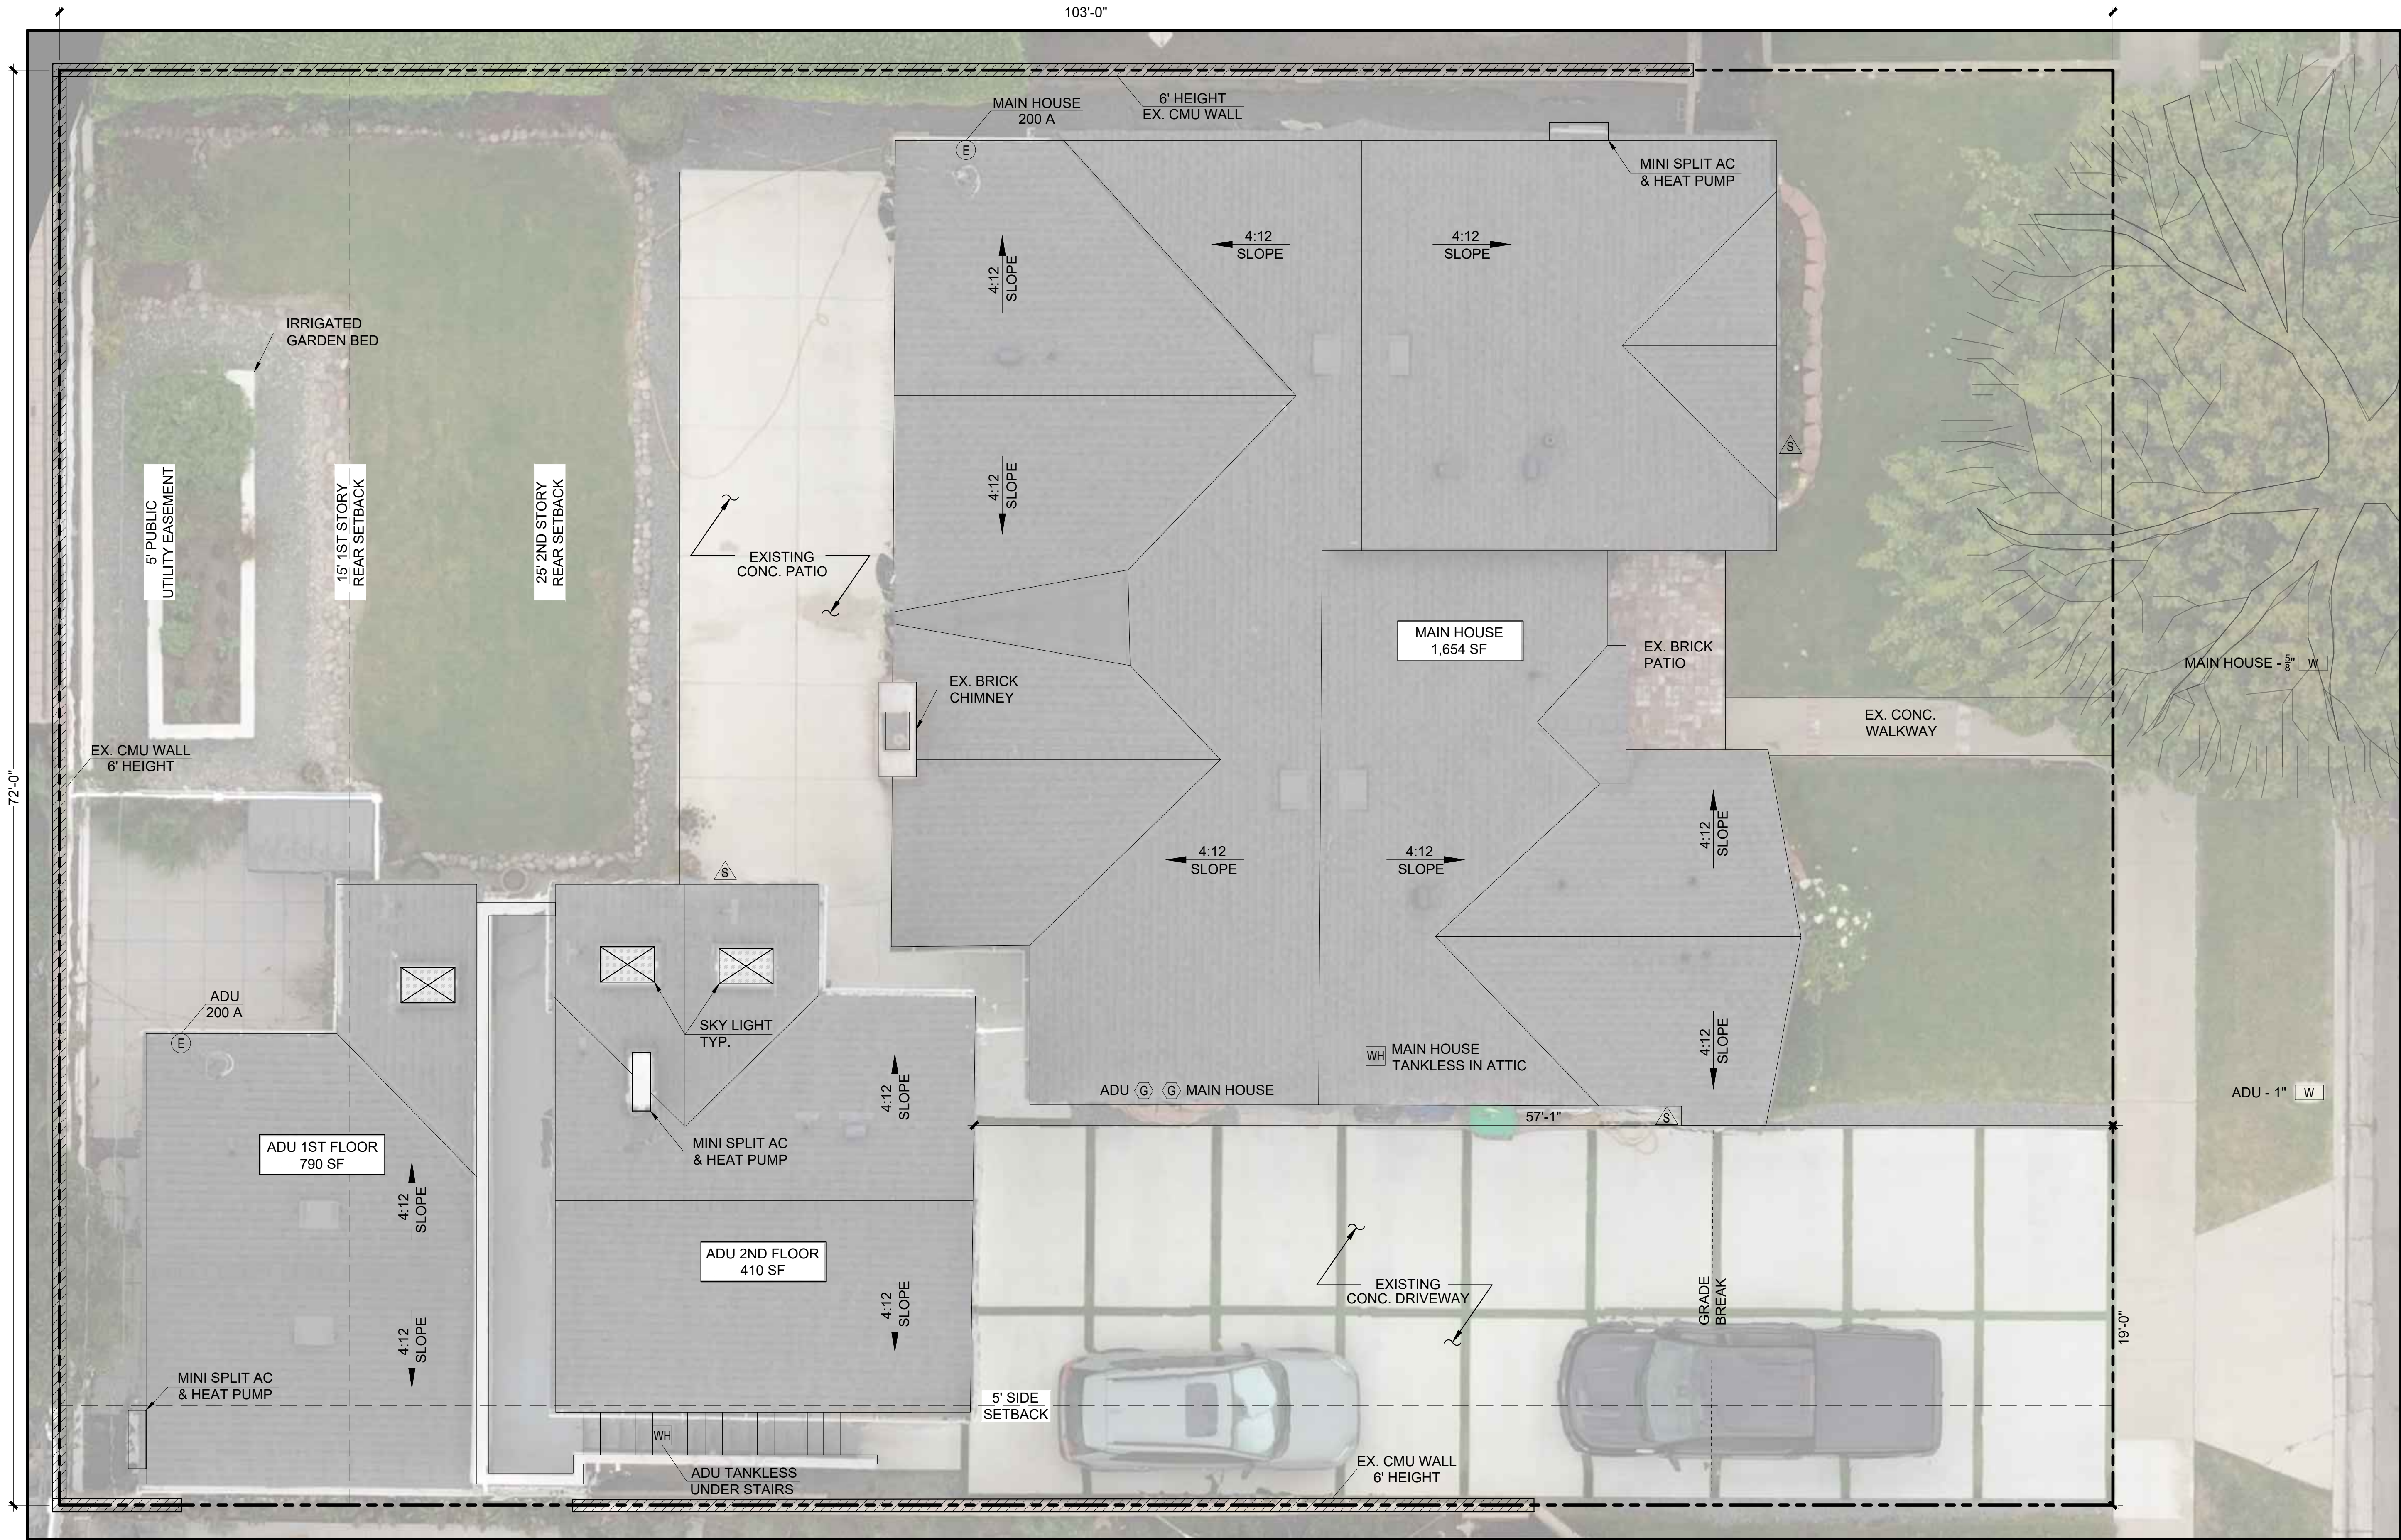


SITE PLAN

SCALE: 1/4"= 1'-0"

LEGEND	
	GAS METER
	WATER METER
	ELECTRICAL PANEL
	WATER HEATER
	SEWER CLEAN OUT
	SKYLIGHT

BLACKBIRD AVE.

SPRUCE ENGINEERING SERVICES,
PROFESSIONAL CORPORATION

5771 GLOUCESTER CIR., WESTMINSTER, CA 92683
TEL: (562) 204-6223
SPRUCEENGINEERING.COM

CHECK AND VERIFY ALL DIMENSIONS
BEFORE PROCEEDING WITH THE
WORK. REPORT DISCREPANCIES
TO THE ENGINEER. ALL
CONSTRUCTION SHALL CONFORM
TO THE C.B.C.

ENGINEER OF RECORD:

BLACKBIRD AVE.

ADDITION AND REMODEL

PROJECT ADDRESS:
9128 BLACKBIRD AVE.
FOUNTAIN VALLEY, CA 92708

REVISIONS			
No.	DATE	SHEET	APPROVAL
1			
2			
3			

DESIGNED BY: JR	DESIGN CHECK BY: JMG
DRAWN BY: JWG	DRAFTING CHECK BY: JMG



SHEET TITLE	
SITE PLAN	
DRAWING REF.	A1.0
PROJECT NUMBER	25-105
SHEET	